


Legend of Symbols & Abbreviations

- Found 1/2" Rebar (Unknown)
- Found 5/8" Rebar (Unknown)
- Found 1/2" Rebar (KVE)
- Found 3" Dia. Aluminum Cap
- Found Chiseled "+"
- Calculated Point
- (M) Measured
- (D) Described

- Bollard
- Power Pole
- Lamp
- Guy Anchor
- Communications Riser
- Flag Pole
- Sign


- Water Valve
- Fire Hydrant
- Water Vault
- Storm Manhole
- Sanitary Sewer Manhole
- Sanitary Clean Out
- Electric Box
- Vault
- Gas Meter
- Gas Test Station
- Gas Marker (KGS)

R/W = Right-Of-Way
UC = Underground Conduit
ET = Electric Transformer
EM = Electric Meter

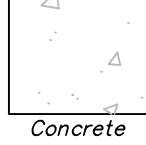

SCALE: 1" = 20'

-20' 0' 10' 20' 40' 60'

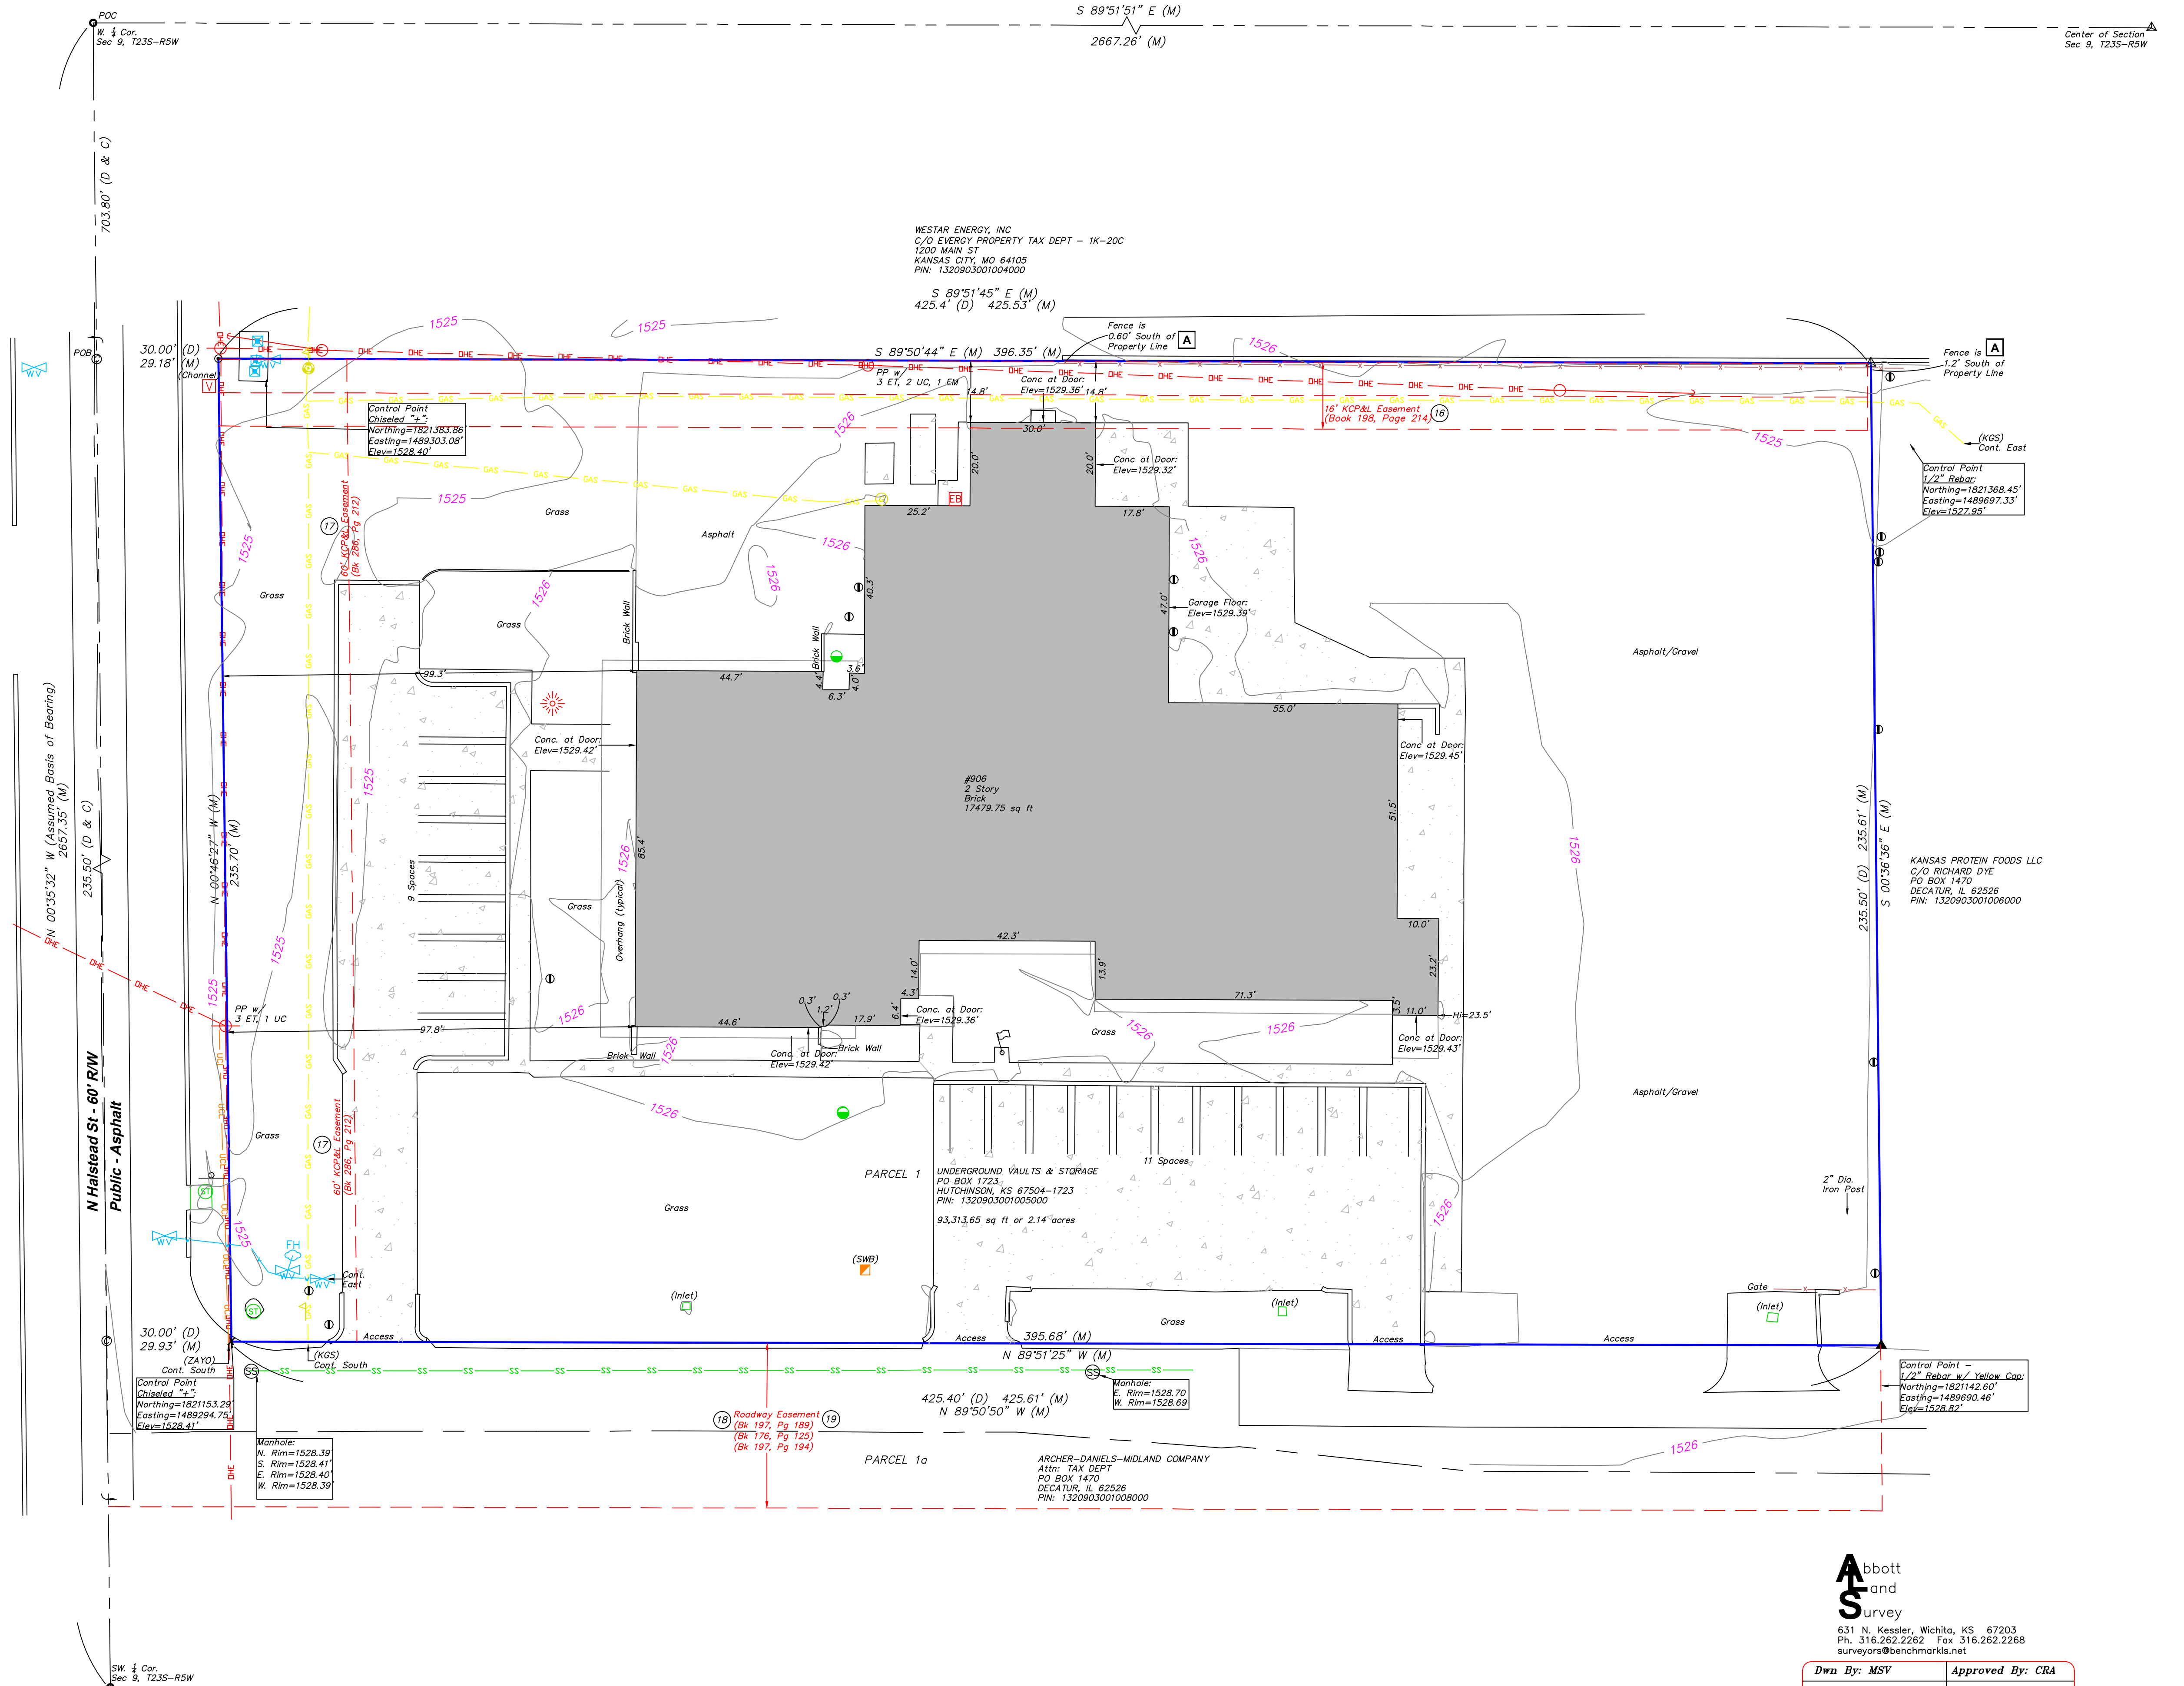

Abbott and Survey

631 N. Kessler, Wichita, KS 67203
Ph. 316.262.2262, Fax 316.262.2268
surveyors@benchmarks.net

Dwg By: MSV Approved By: CRA
Dwg No: A25-06-053 Scale: 1" = 20'